
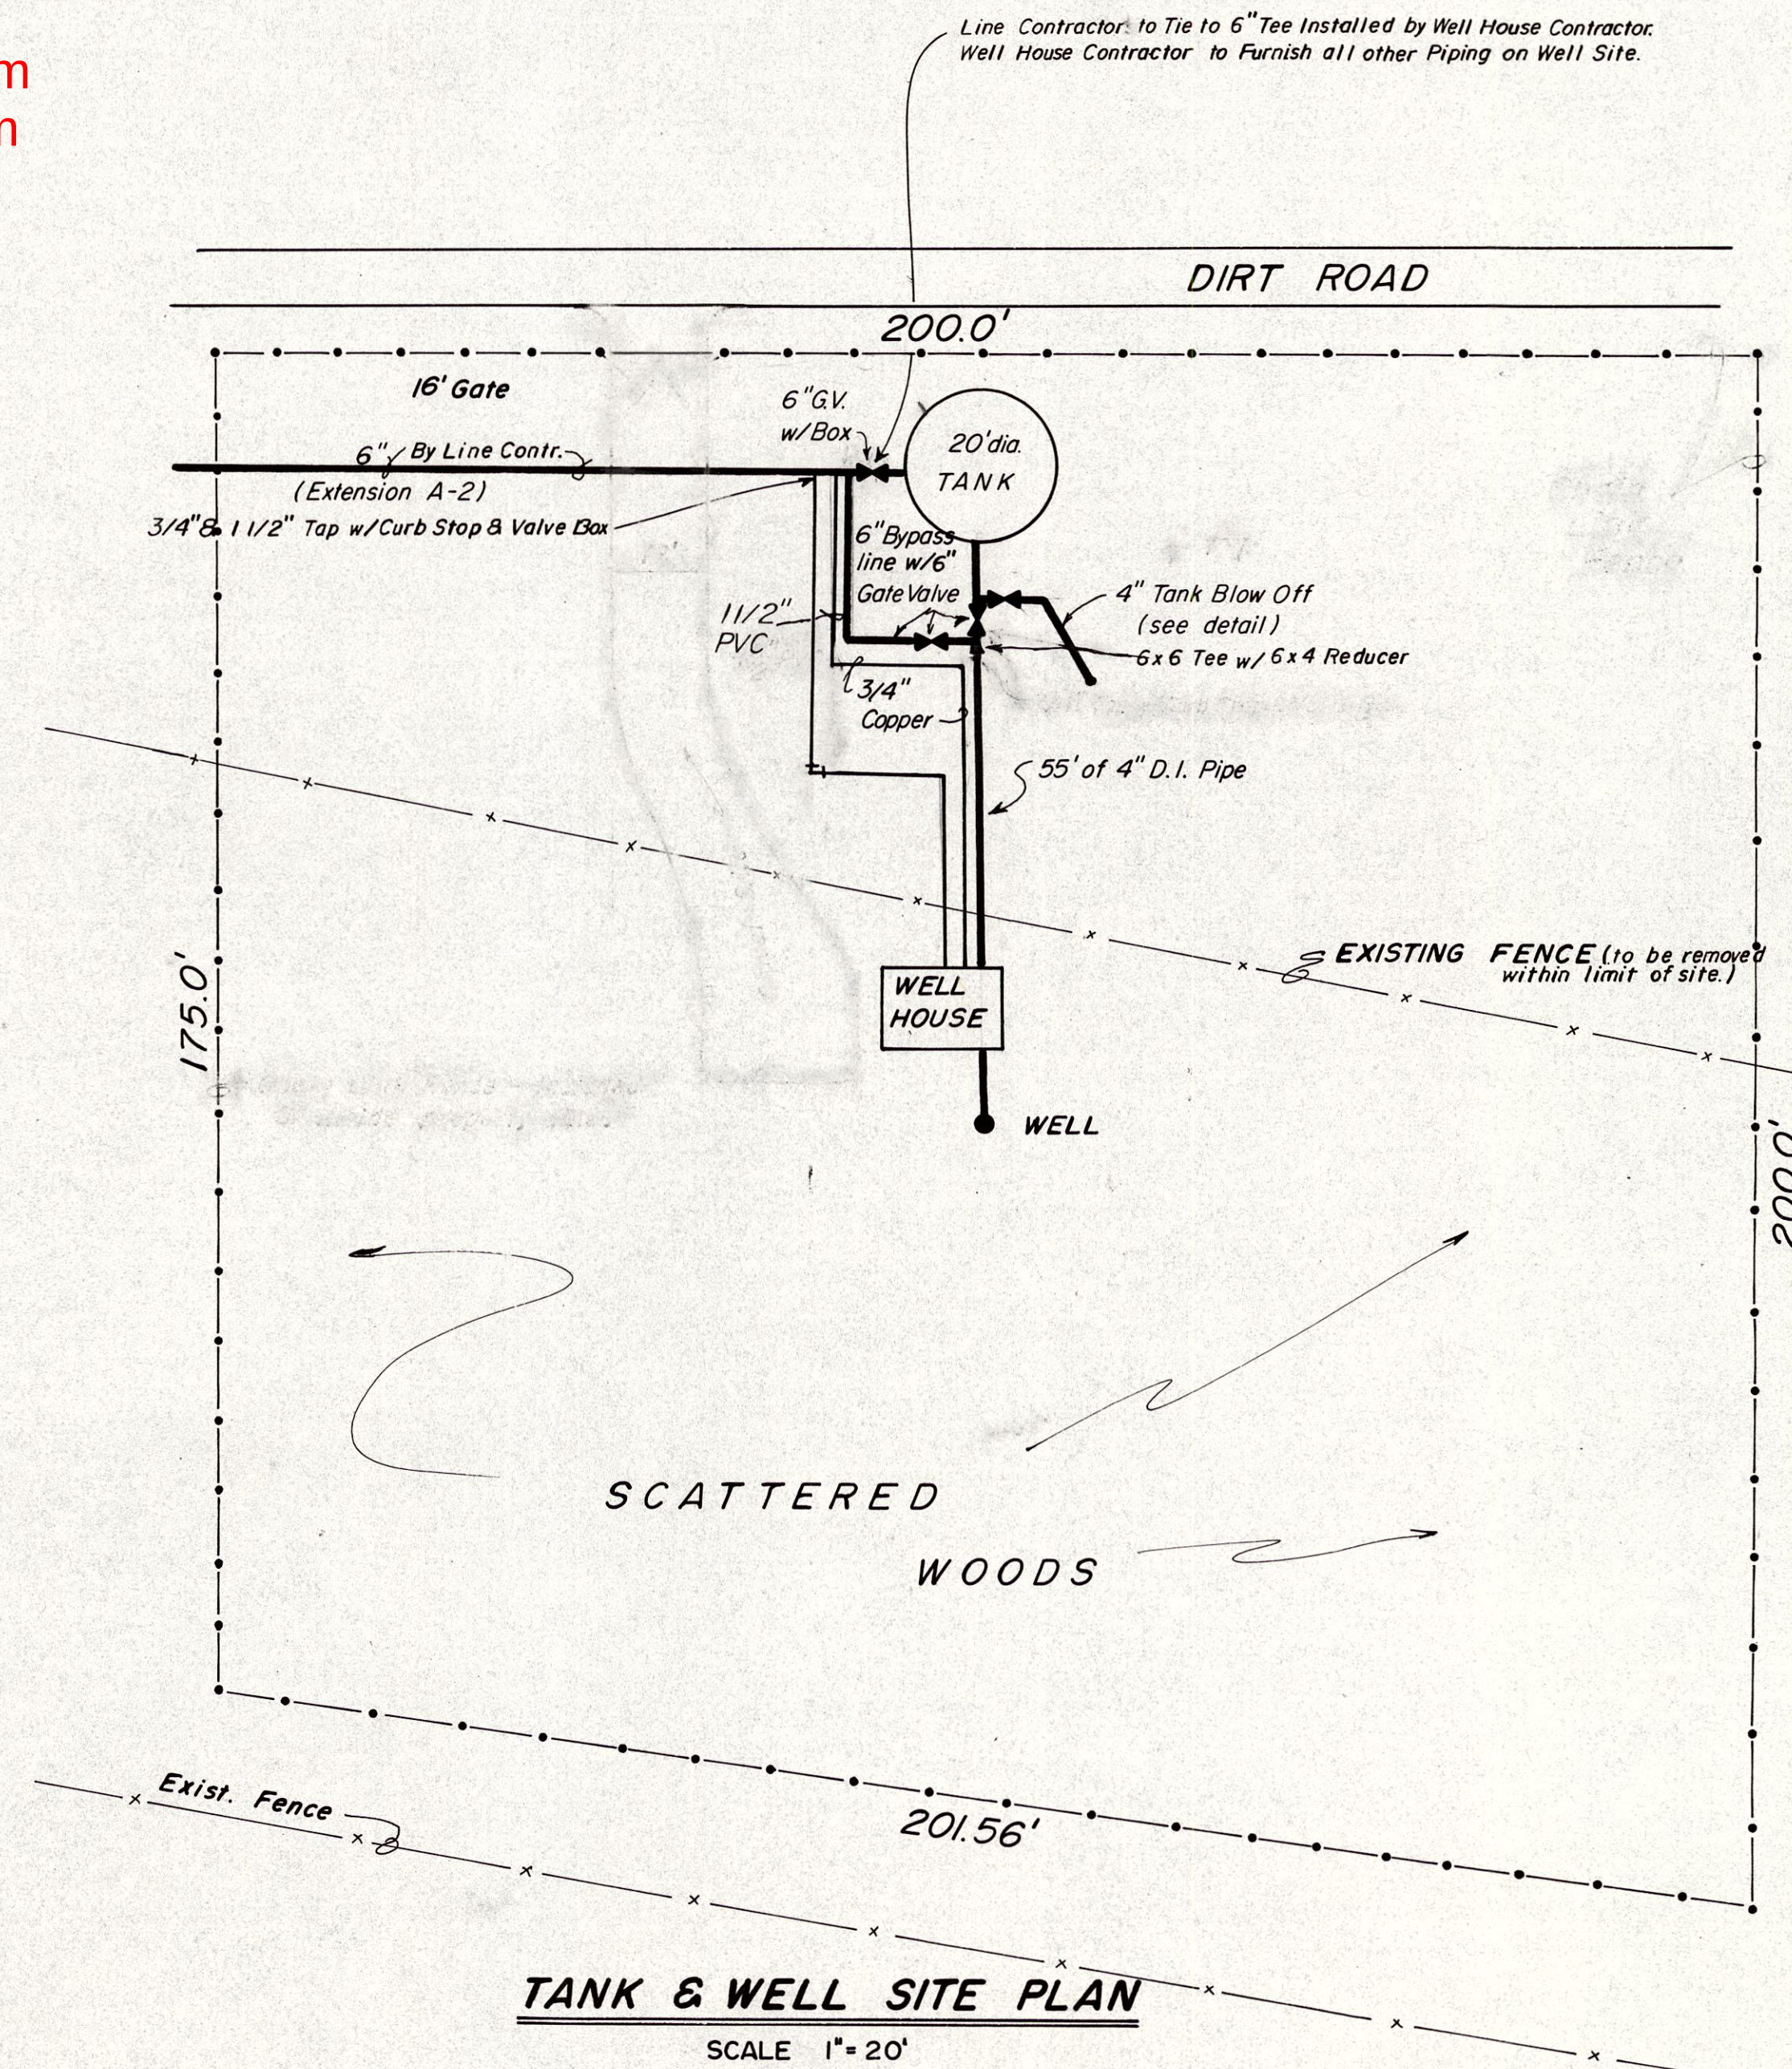


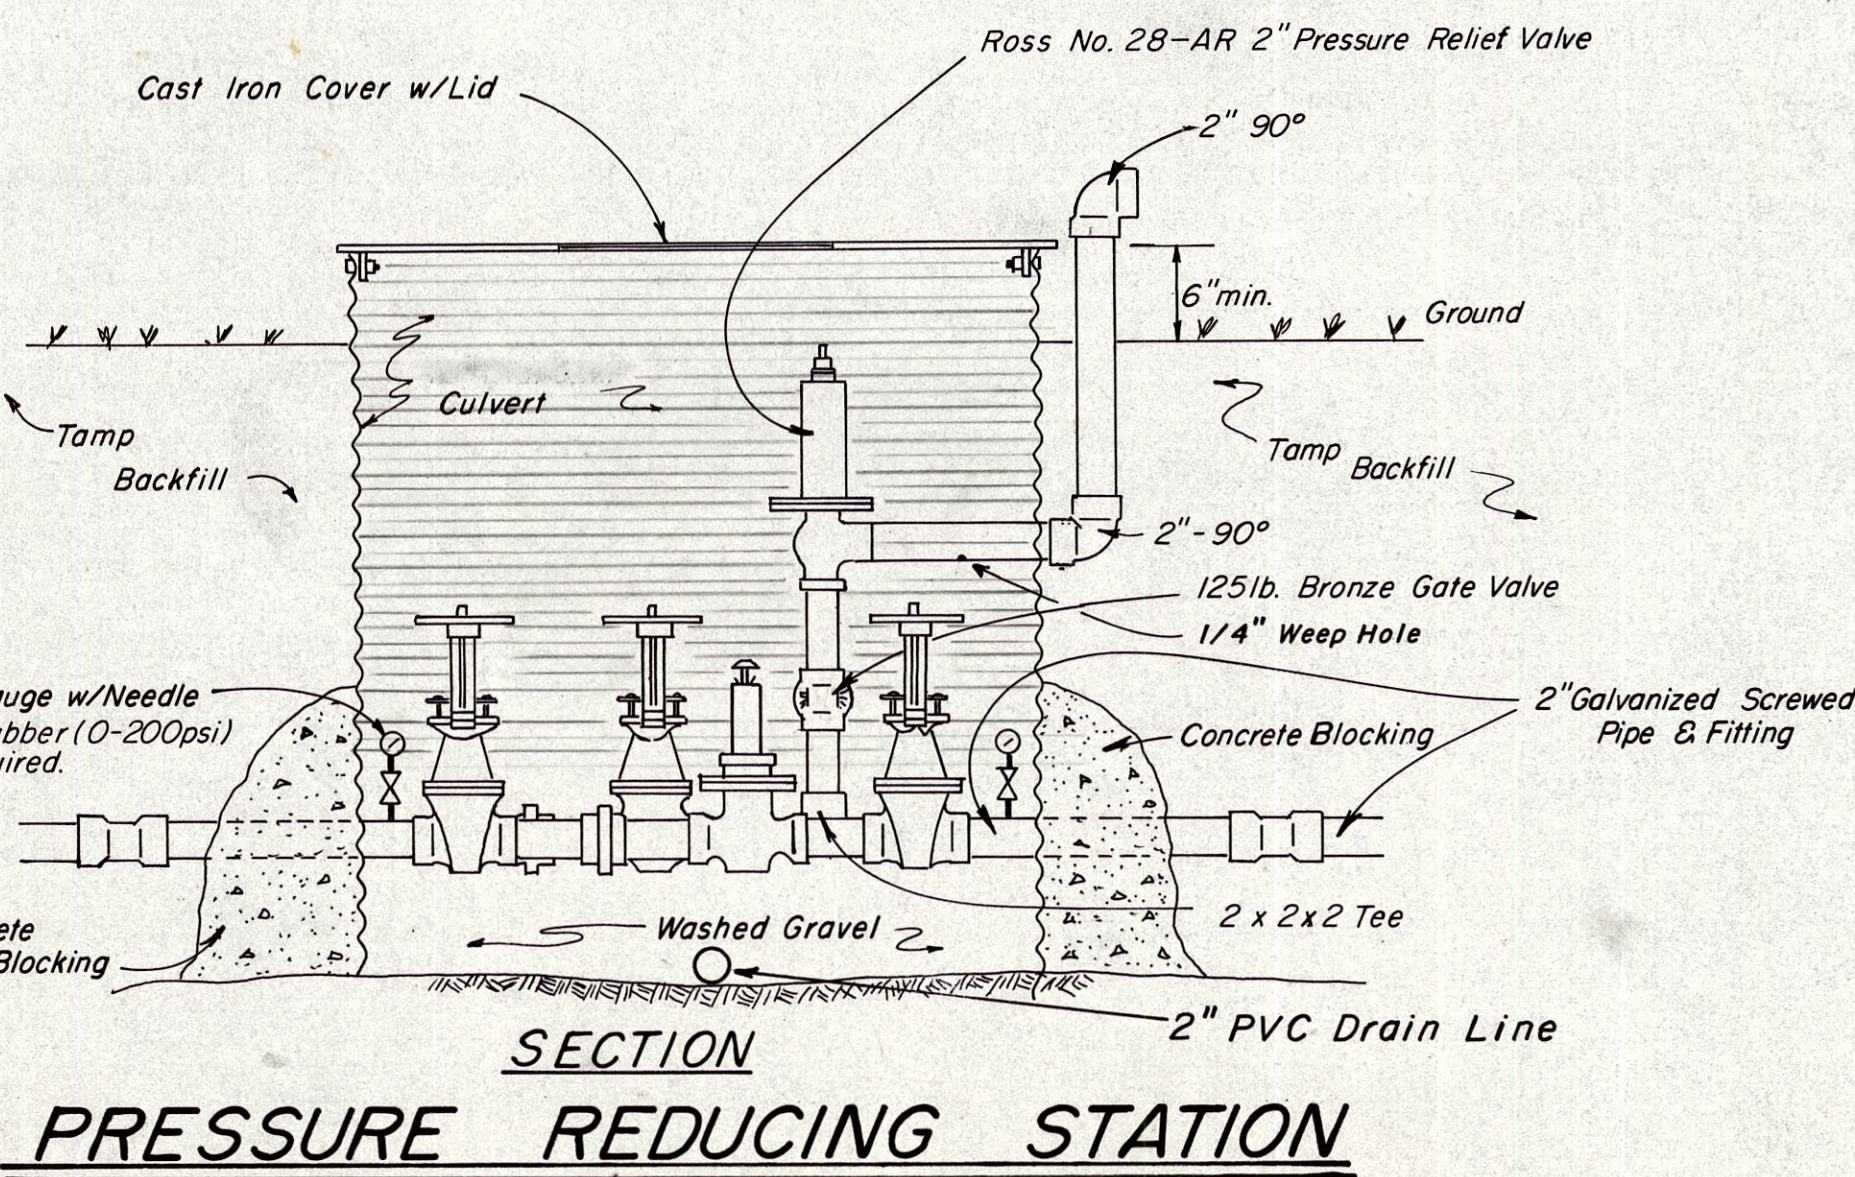

DATE		REVISIONS	
SURVEY BY:			
DESIGN BY: E. T. S.			
DRAWN BY:			
CHECKED BY: E.T.S.			
MT. SHERMAN WATER ASSOCIATION NEWTON COUNTY, ARKANSAS		EXT. A-2, SITE PLAN, PRESSURE REDUCING STATION	
 BLAYLOCK, THREET & ASSOCIATES, INC. Consulting Engineers MECHANICAL-ELECTRICAL CIVIL-SURVEYING 1501 MARKET DRIVE LITTLE ROCK, ARKANSAS			
			
SCALE 1" = 100'			
DATE		PROJECT NO.	
APR. 1982		80 055 2	
SHEET		OF	
12		29	