
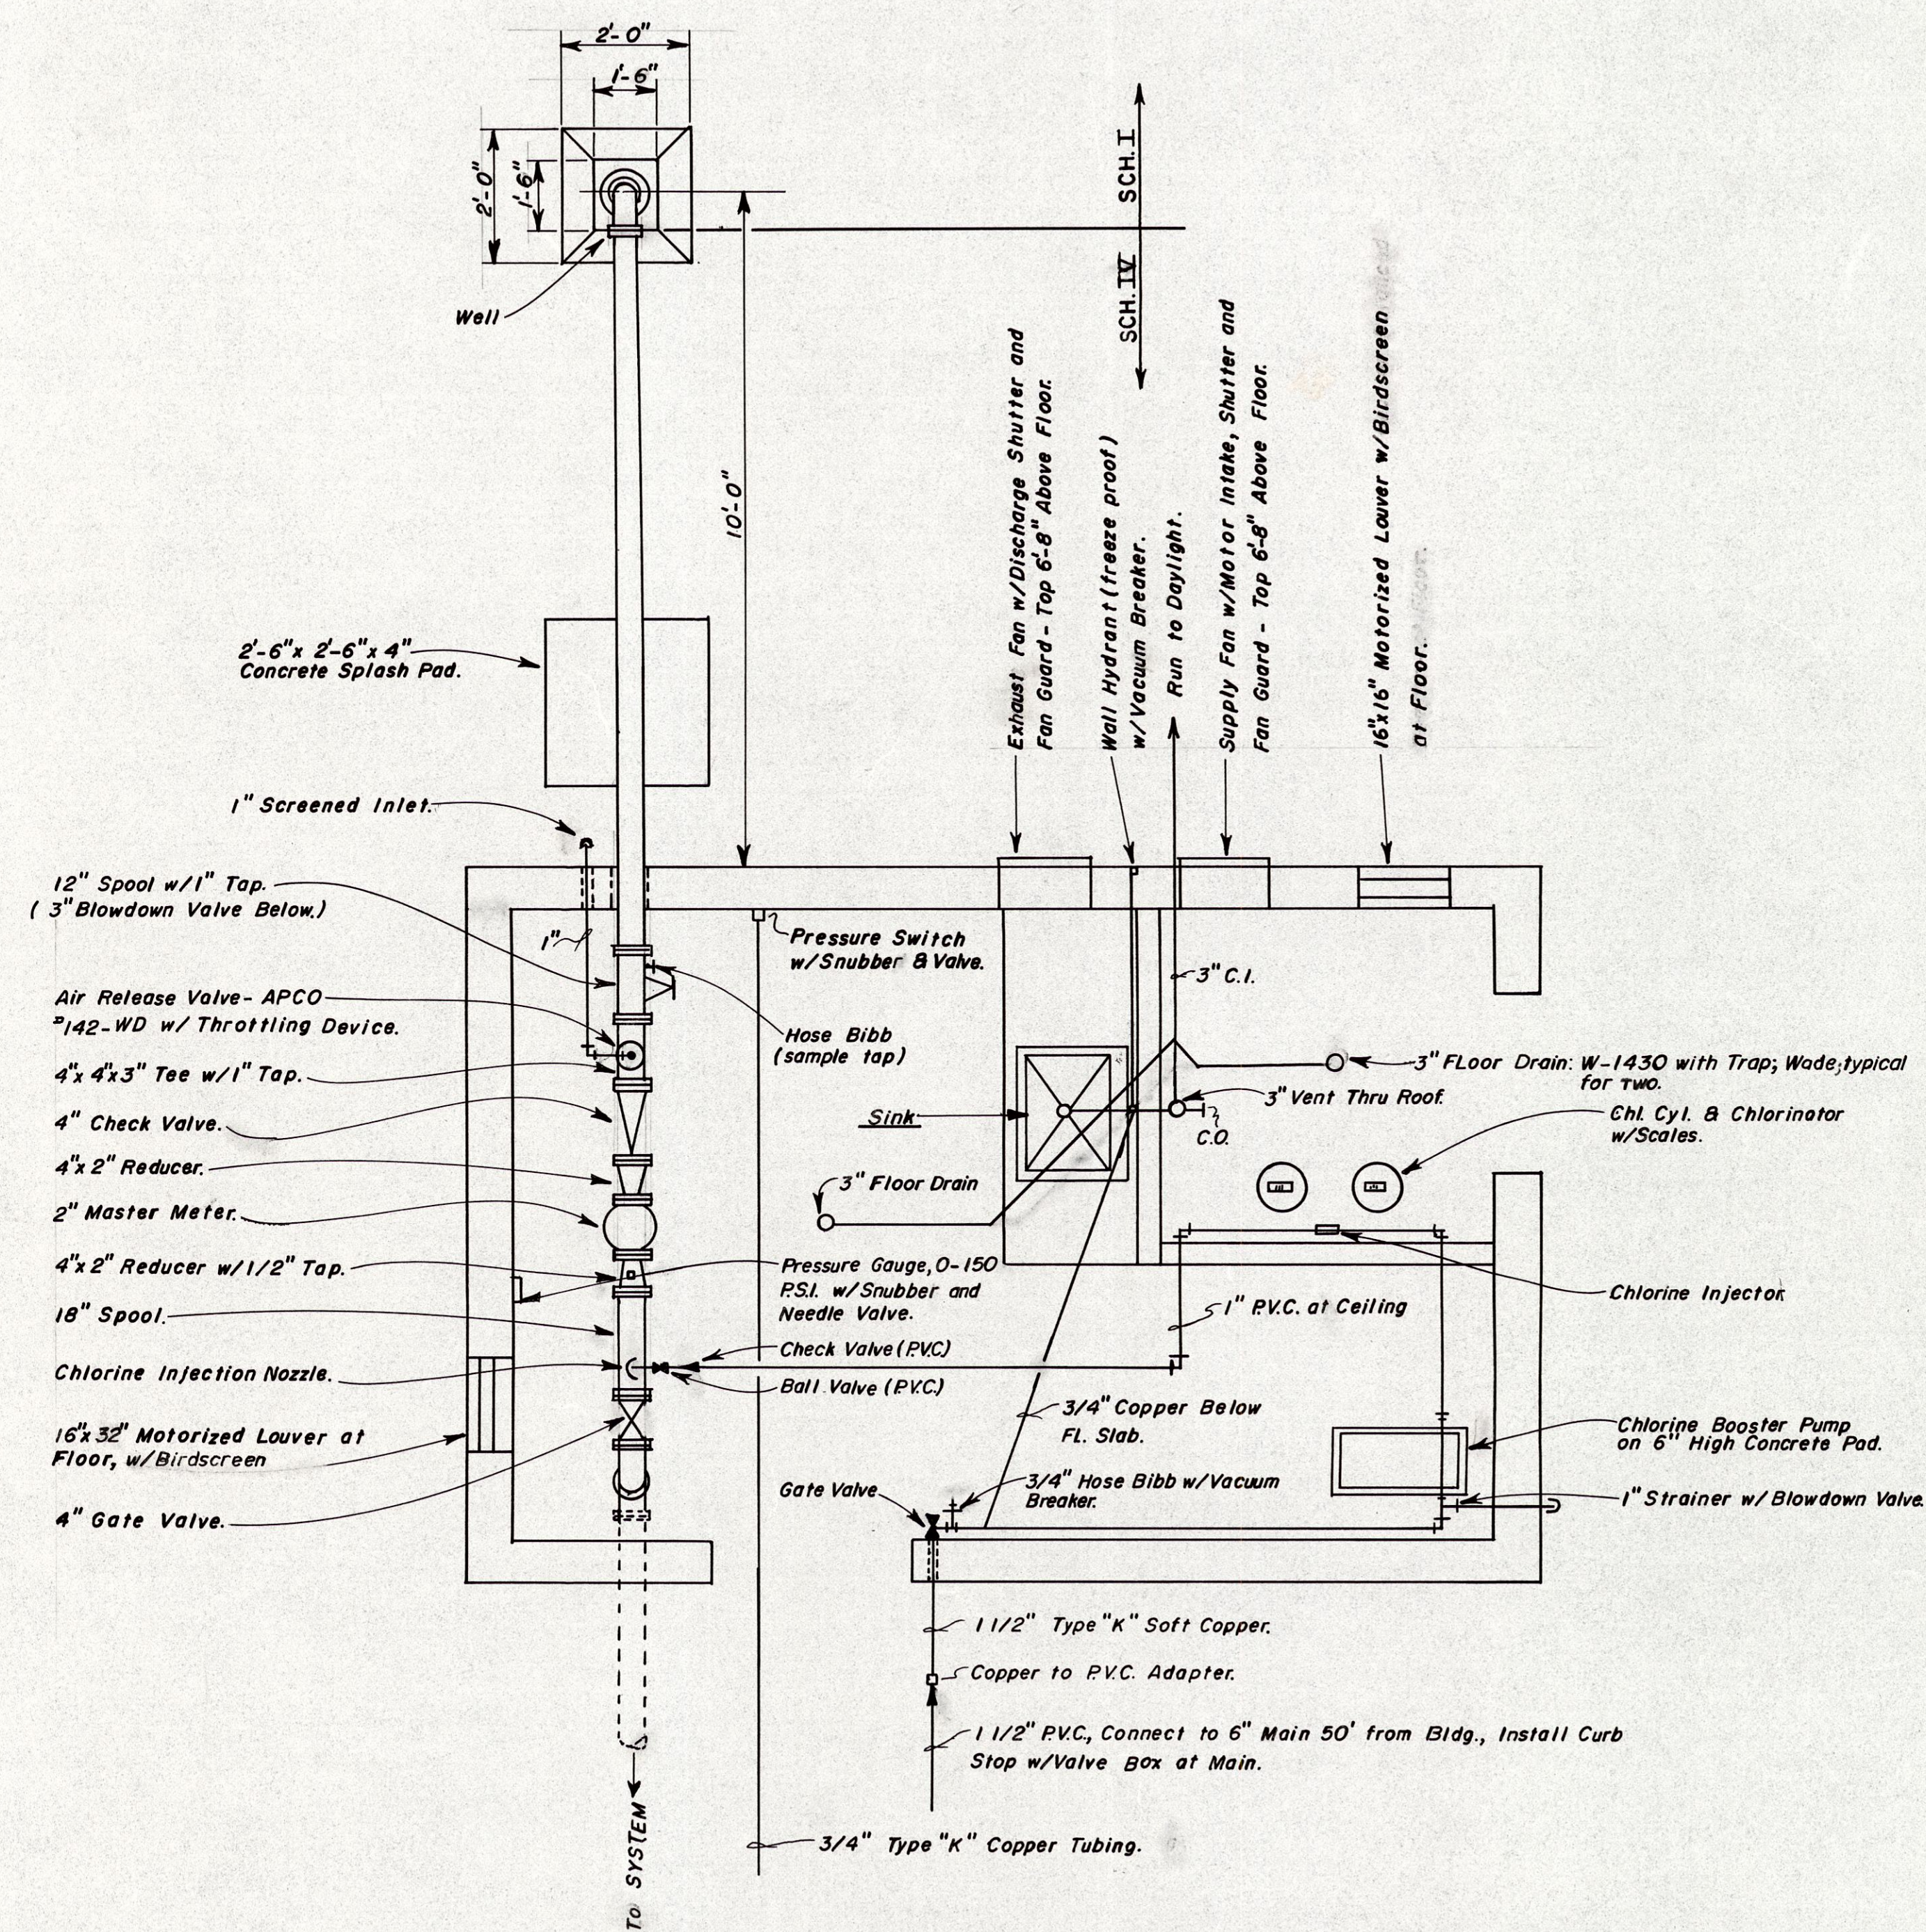
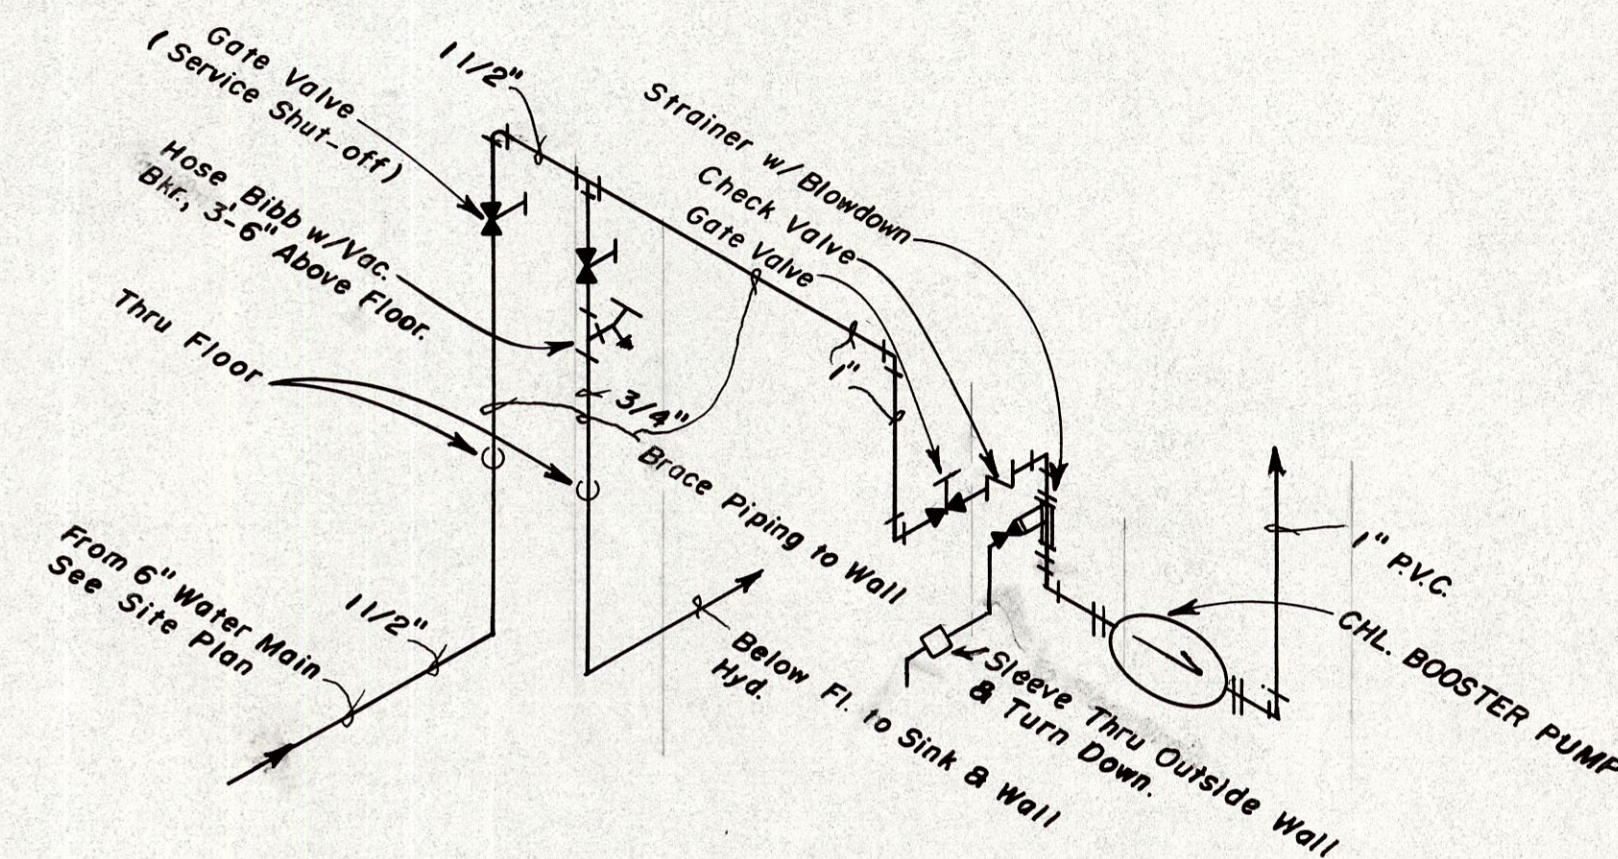
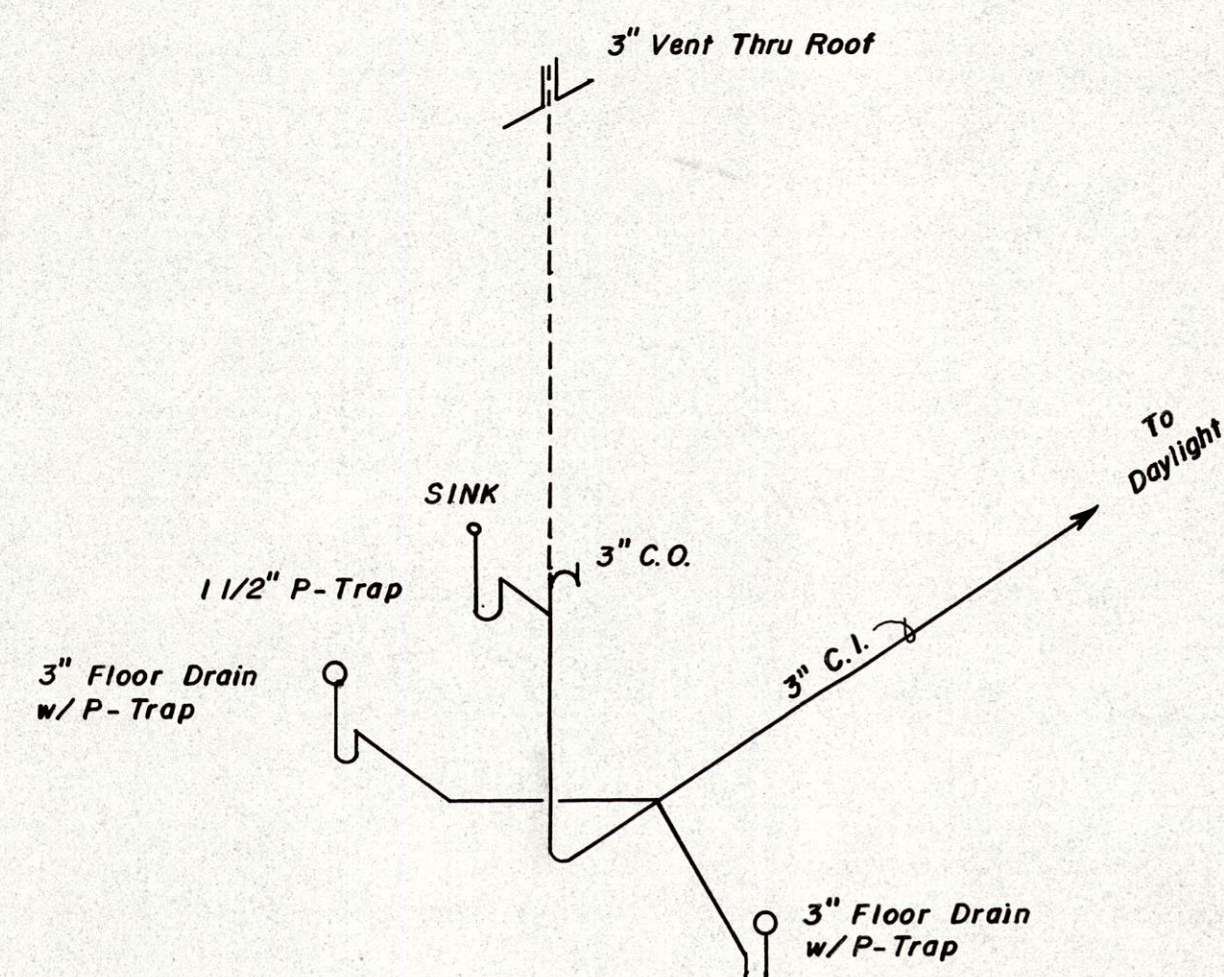


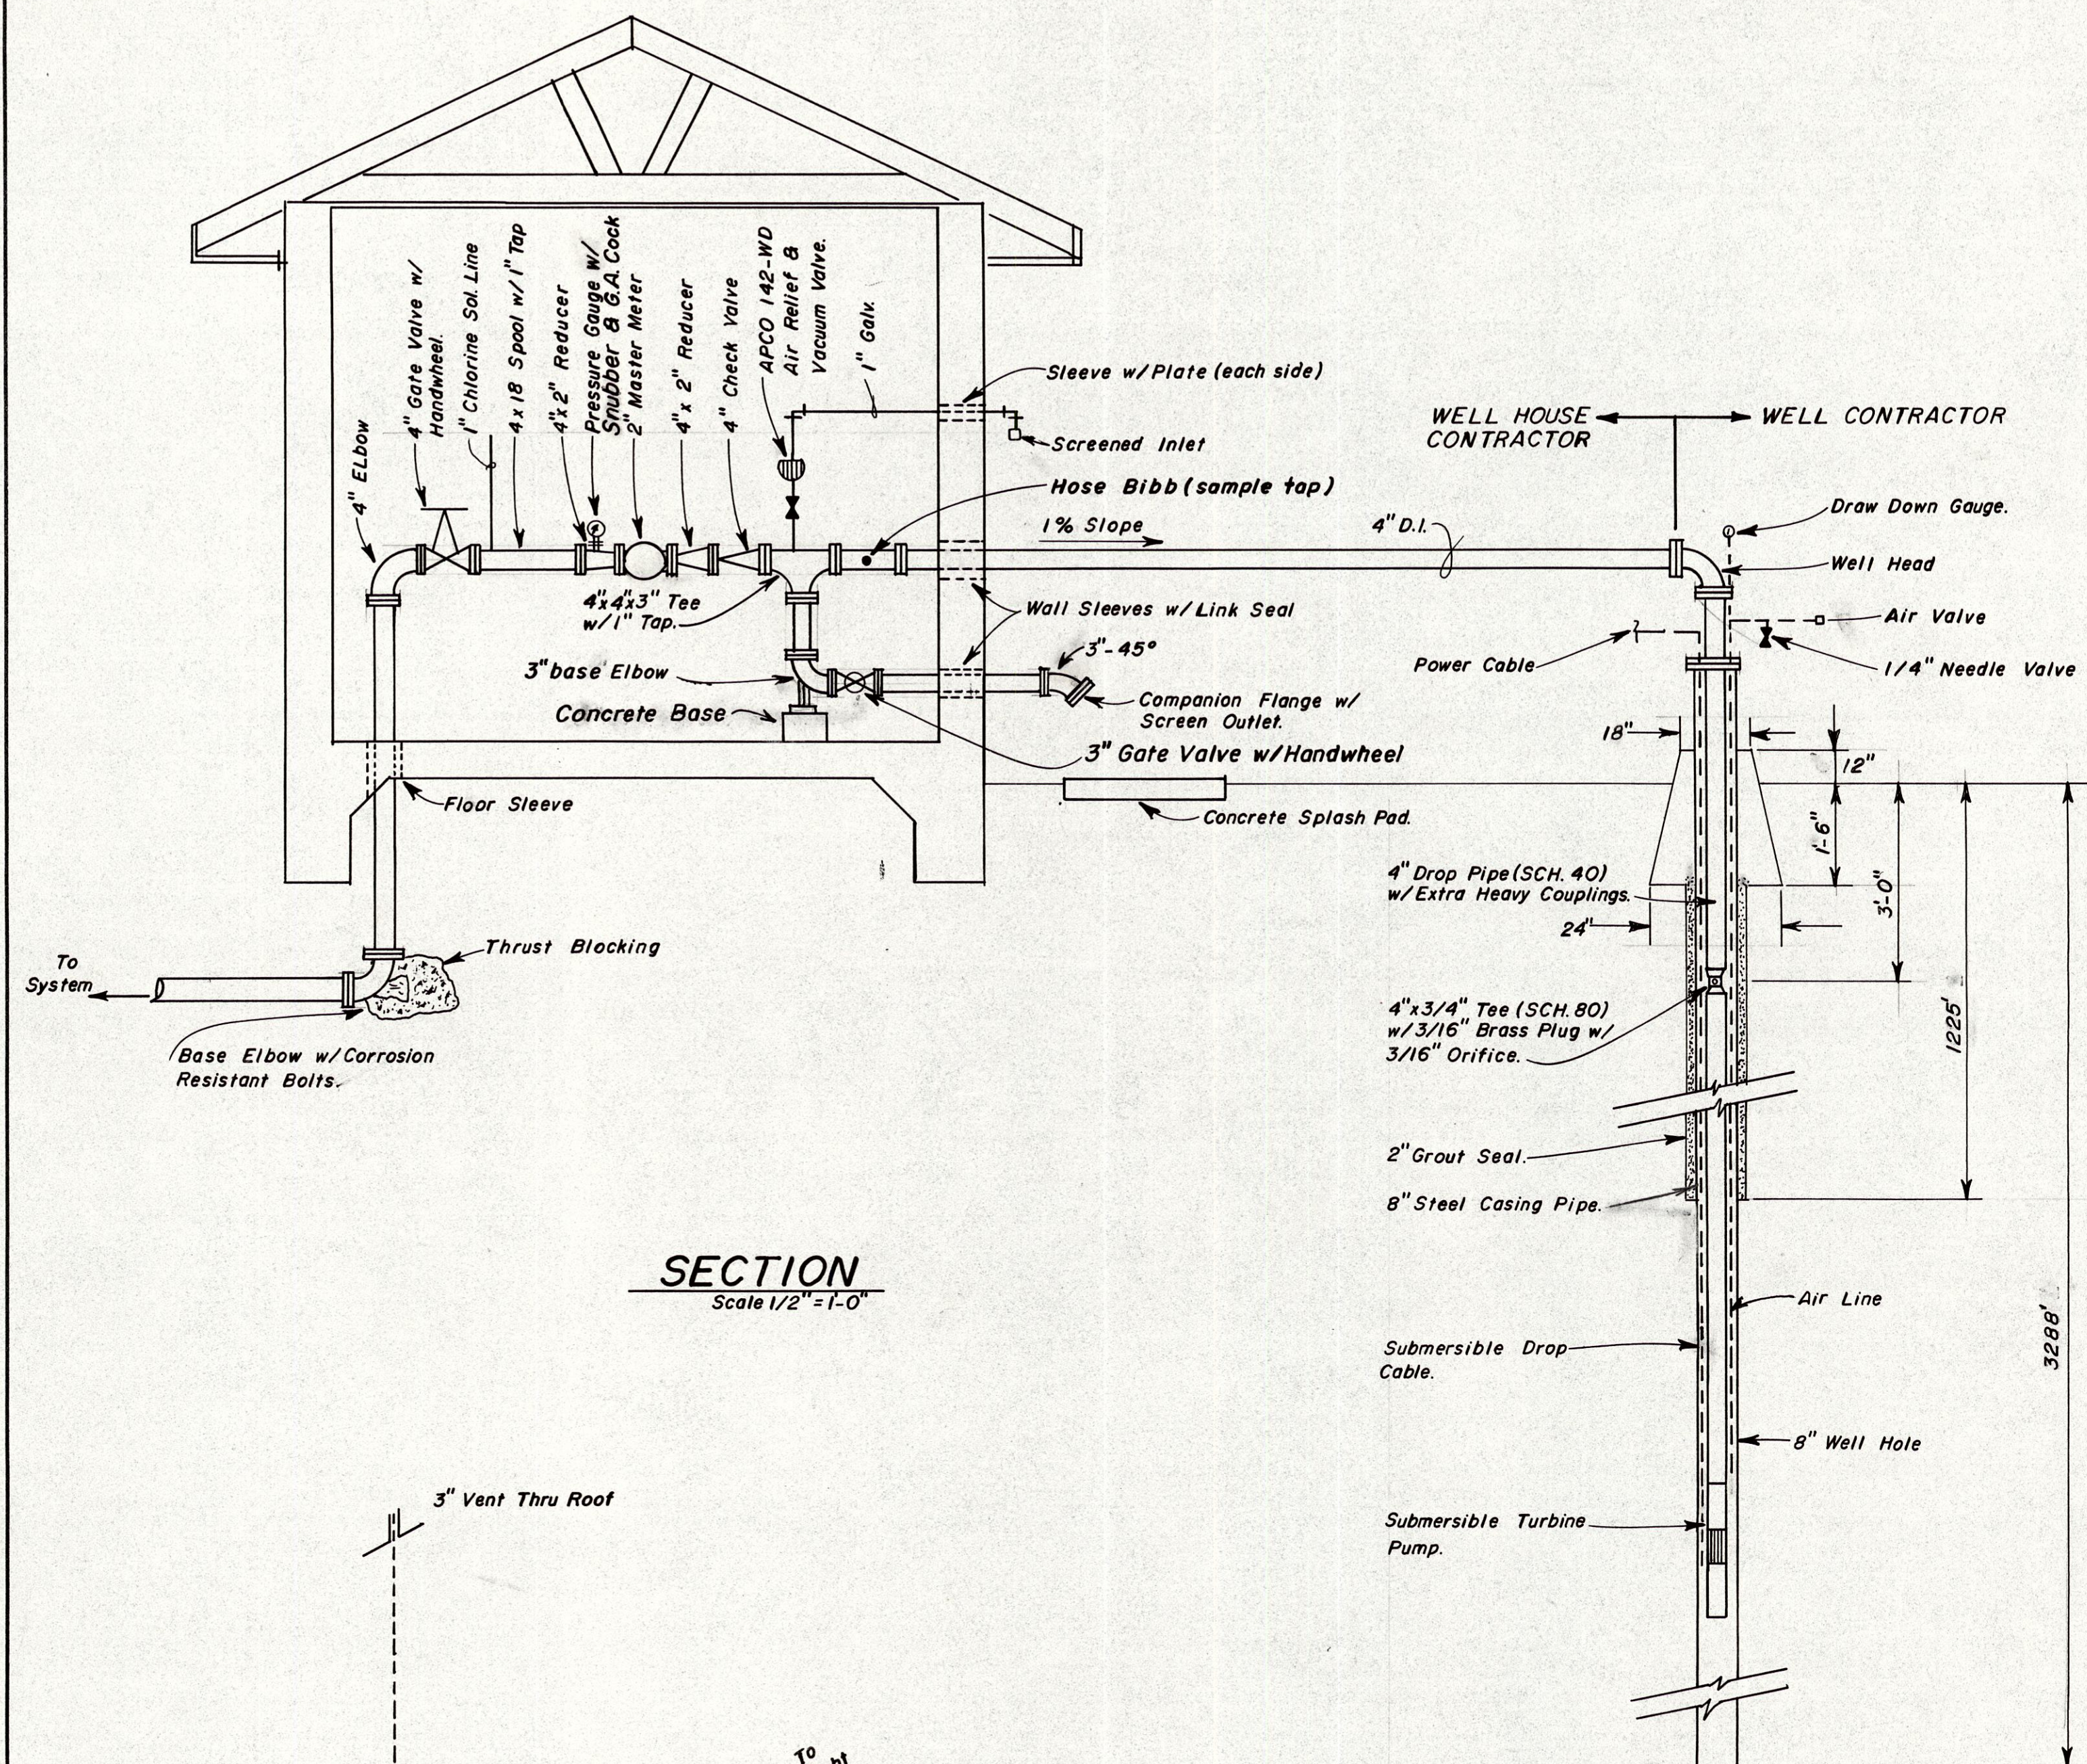

NOTE:
Exhaust Fans & Louvers Shall be Furnished by Electrical Contractor; See Sheet 27 of 29.

DATE	REVISIONS


SURVEY BY:

DESIGN BY: E.T.S.


DRAWN BY: M.L.K.

CHECKED BY: E.T.S.

MT. SHERMAN WATER ASSOCIATION	
NEWTON COUNTY	ARKANSAS
WELL HOUSE MECHANICAL DETAILS	

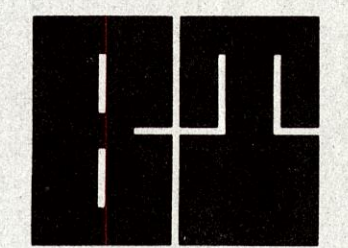

**Consulting
Engineers**
MECHANICAL-ELECTRICAL
CIVIL-SURVEYING
1501 MARKET DRIVE
LITTLE ROCK, ARKANSAS

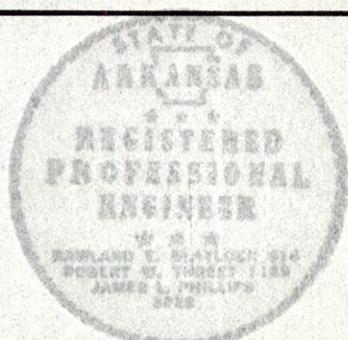

SCALE	
AS SHOWN	
DATE	PROJECT NO.
APR. 1982	80-055-2
SHEET 26 OF 29	